





**PROGRESS PRINT**  
 5/19/2023 3:30:40 PM

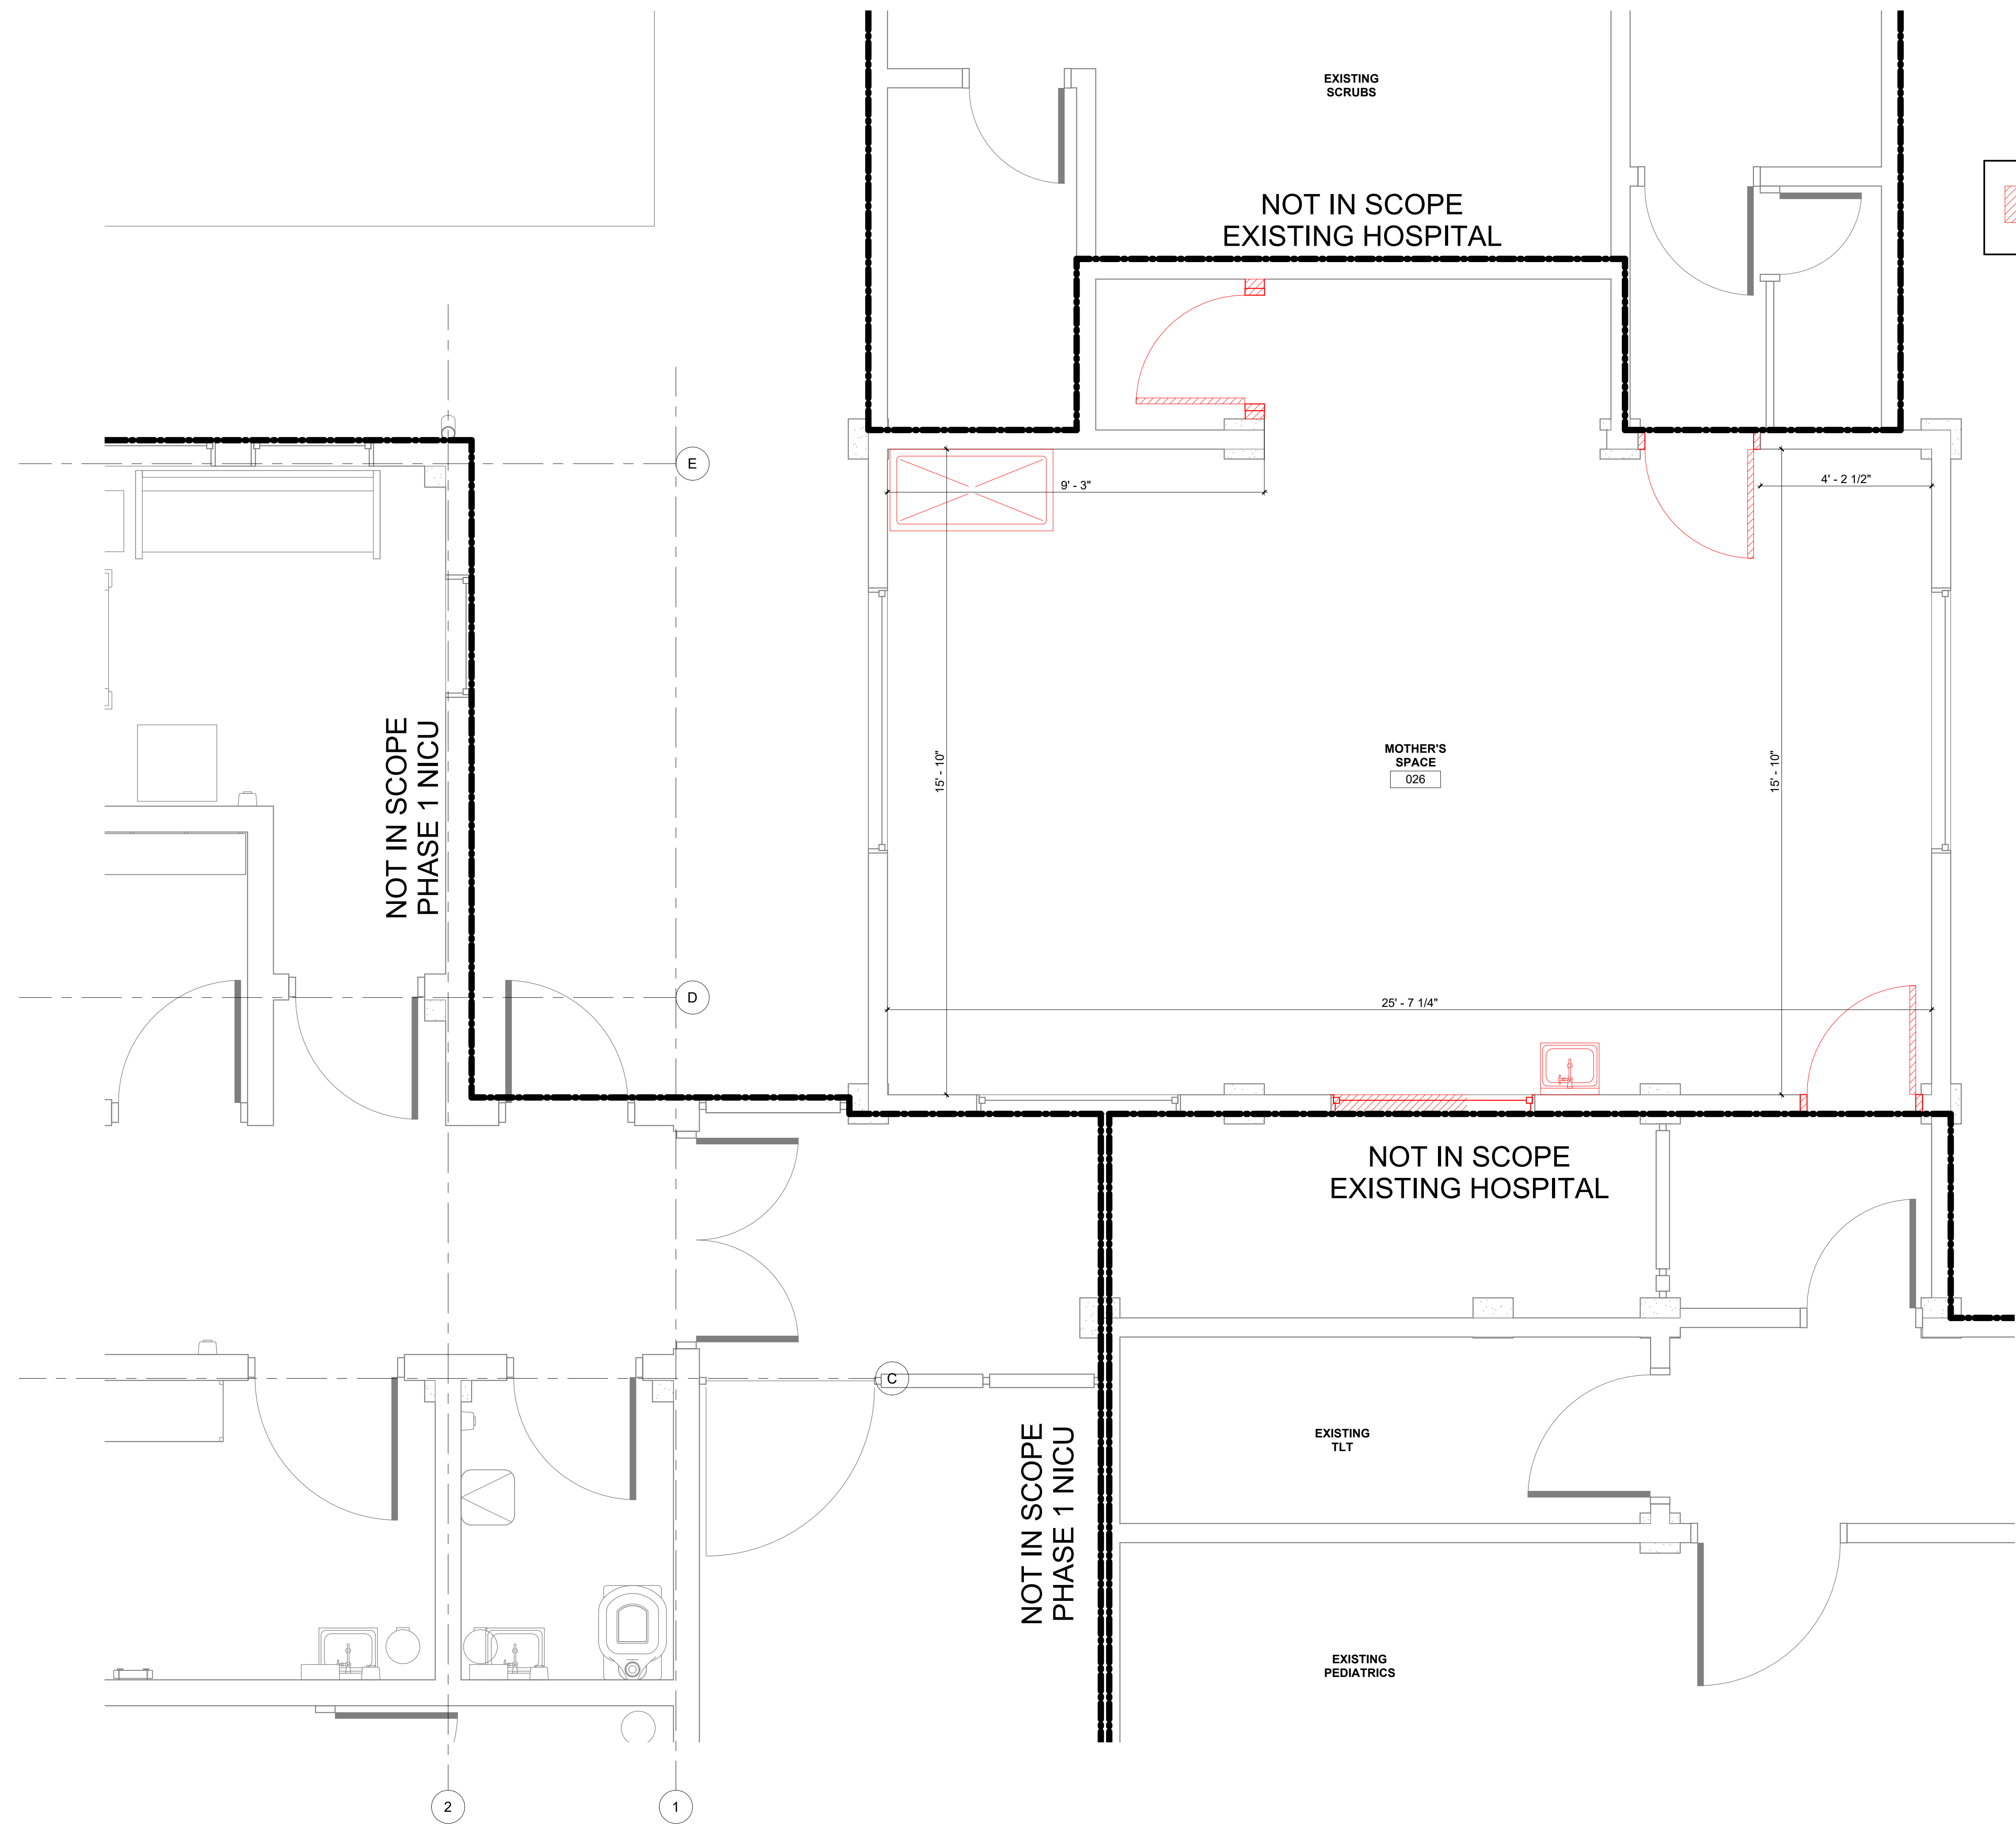


 TO BE DEMOLISHED

**1 PHASE 2 DEMO PLAN**  
 SCALE 1 : 25

NO.	DATE	DESCRIPTION
-----	------	-------------

KEY PLAN			
<b>HOPE HEALTH ACTION</b>			
OWNER			
<b>MOTHER'S ROOM RENOVATION</b>			
PROJECT			
HCBH HOSPITAL, QUARTIER MORIN, HAITI			
DRAWING TITLE			
<b>DEMO PLAN</b>			
SCALE	DATE		
1 : 25	03/22/23		
JOB NUMBER			
64-001			
DRAWN	AUTHOR	CHECKED	CHECKER
PHASE 2 CONSTRUCTION DRAWINGS			
<b>A001-2</b>			
DRAWING NUMBER			

**PROGRESS PRINT**  
 6/2/2023 2:05:32 PM

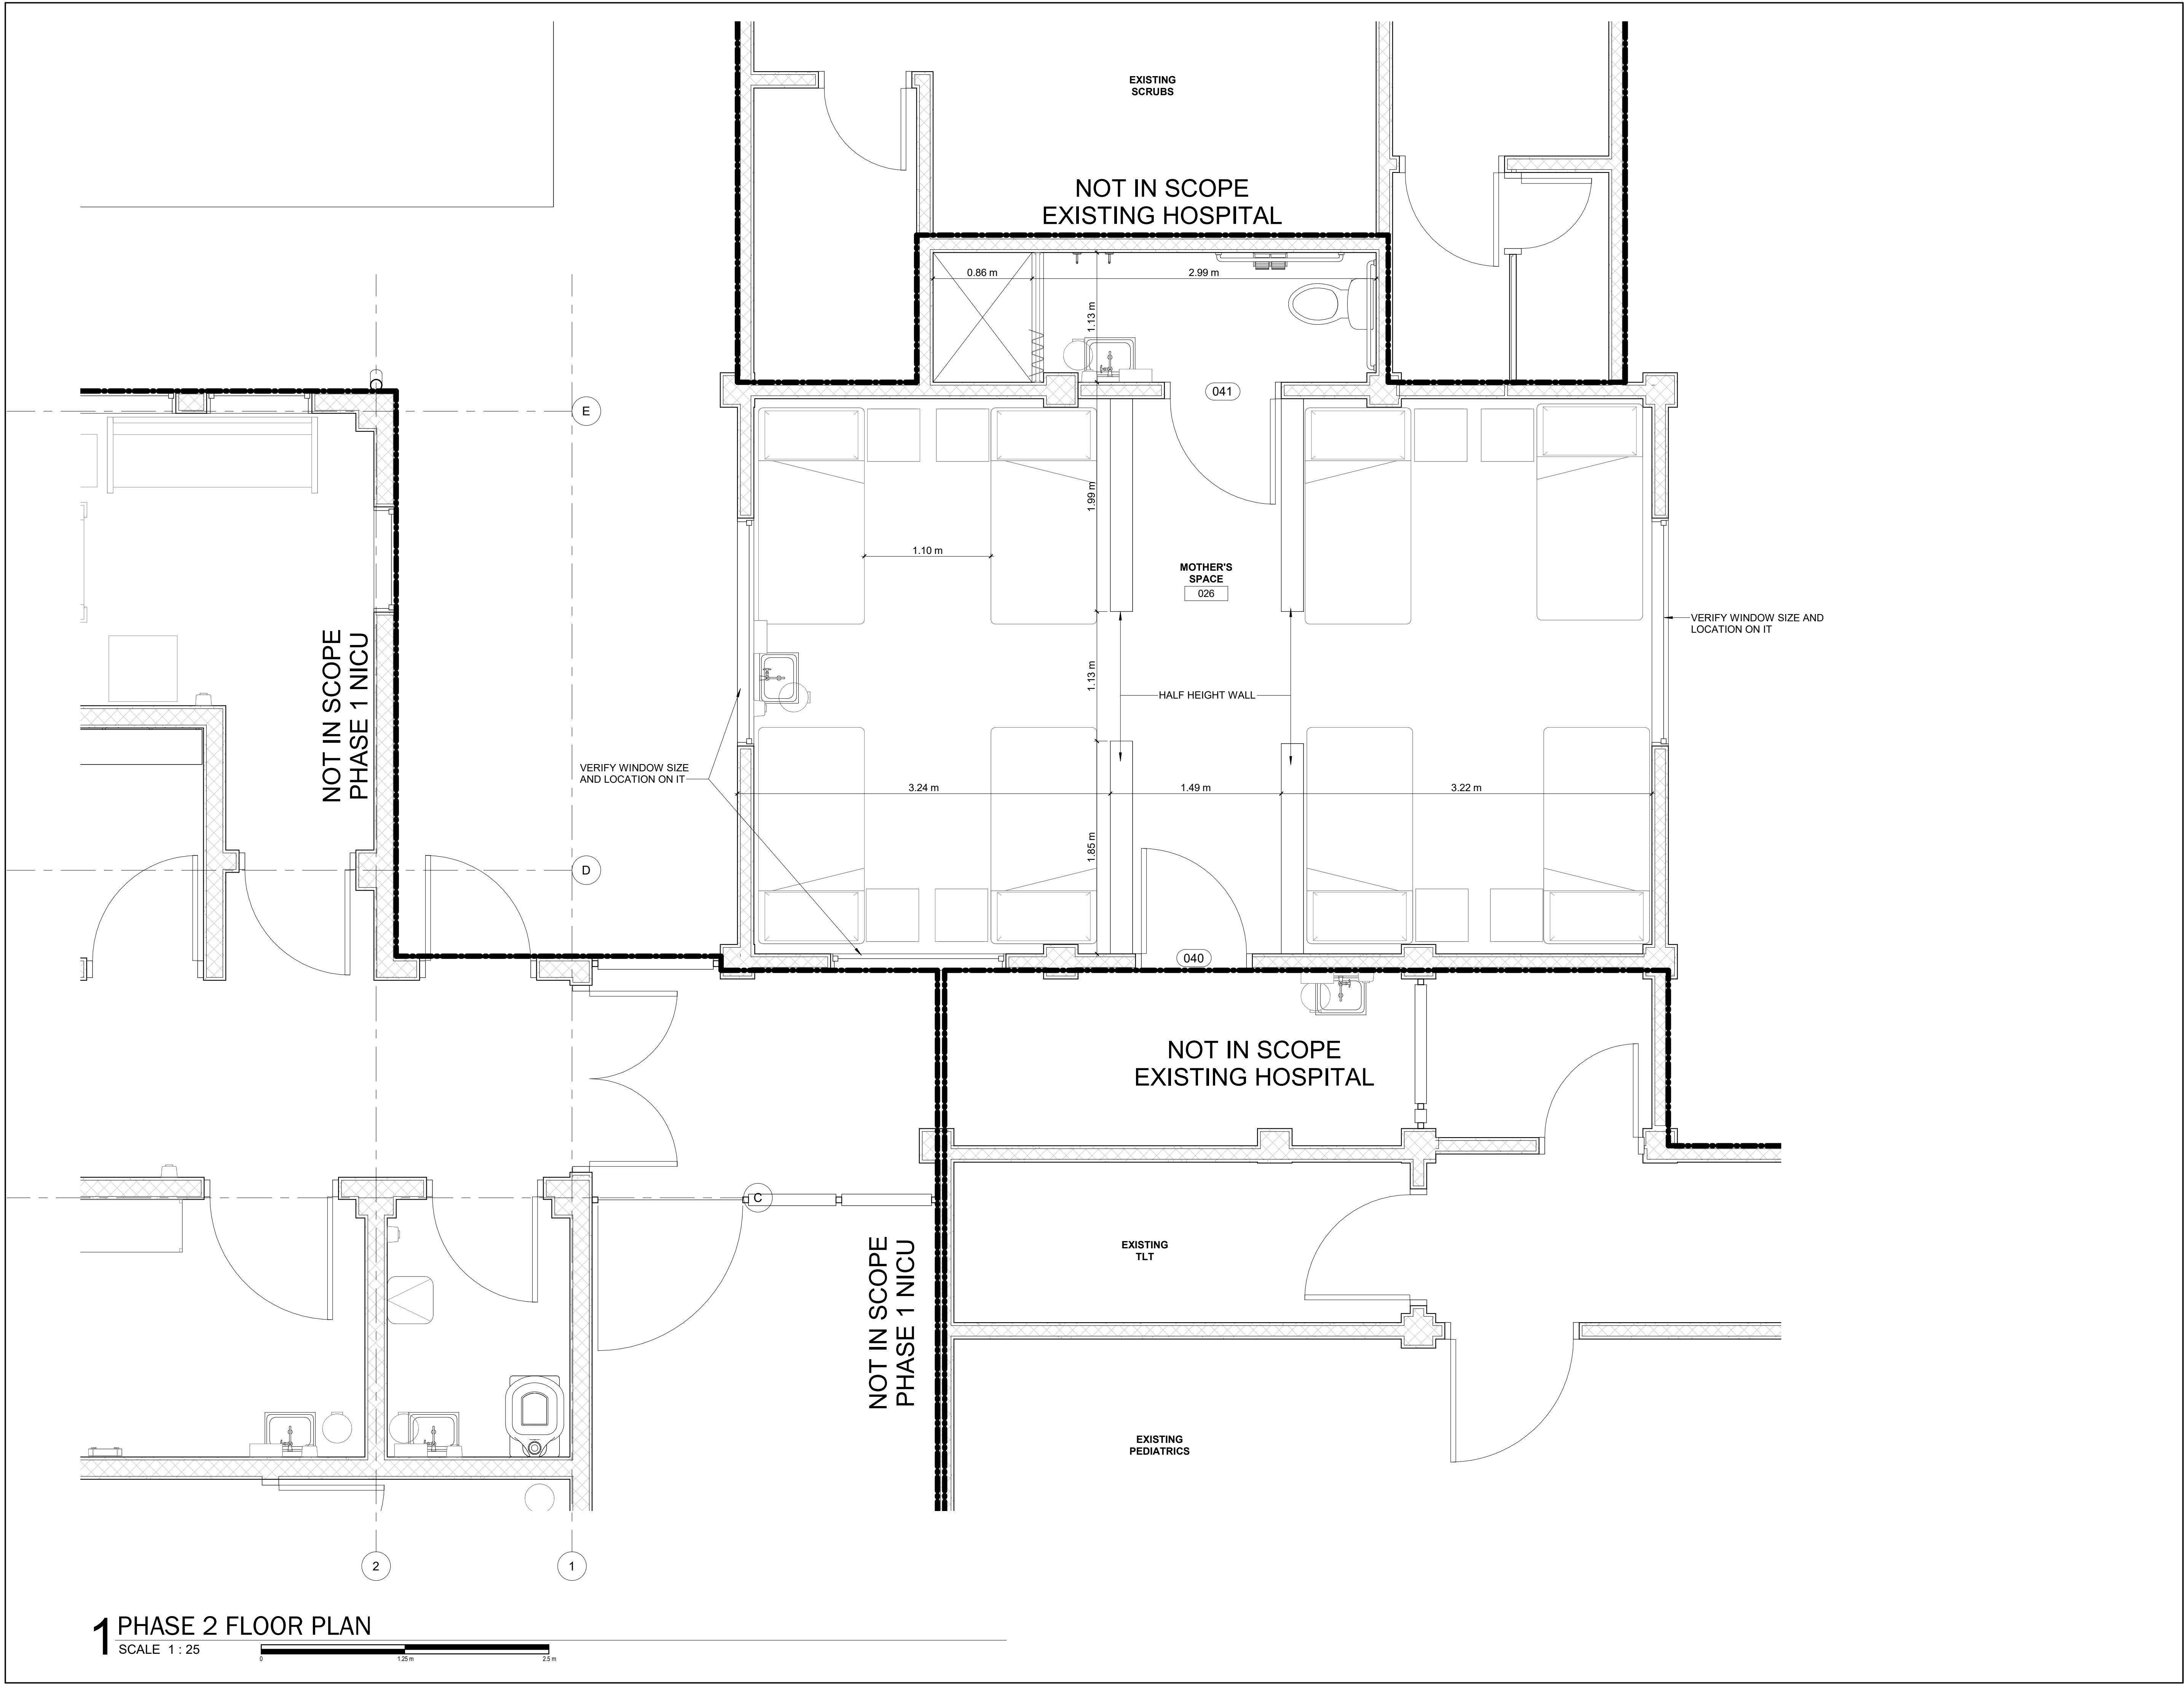

NO.	DATE	DESCRIPTION
-----	------	-------------

KEY PLAN

**HOPE HEALTH ACTION**

OWNER

**MOTHER'S ROOM RENOVATION**  
 HCBH HOSPITAL, QUARTIER MORIN, HAITI

PROJECT

**FLOOR PLAN**

DRAWING TITLE

SCALE 1 : 25 DATE 03/22/23

JOB NUMBER 64-001

DRAWN Author CHECKED Checker

PHASE 2 CONSTRUCTION DRAWINGS

**A101-2**

DRAWING NUMBER


6/2/2023 2:05:32 PM  
 A:\bchh\Draw\064-001-HHA-ME64-001\_HHA-MR-MO-NICU\_A\_2023.rvt  
 MOTHER'S ROOM RENOVATION

**1 PHASE 2 FLOOR PLAN**  
 SCALE 1 : 25



**PROGRESS PRINT**  
5/19/2023 3:30:43 PM

Door Schedule - Phase 2																			
Door No.	Room		To Room: Name	Door Type	Door Material	Swing	Opening Dimensions					Frame		Door Louver	Door Lite	Lockset	Hinges	Closer	
	From	To					Nominal Size		Finished Opening		Rough Opening		Frame Material						Frame Type
							Width	Height	Finished Width	Finished Height	Rough Width	Rough Height							
040	026	MOTHER'S SPACE	D1-91-S	Wood	RHR	0.91 m	2.13 m	1.02 m	2.18 m	1.07 m	2.21 m	HM	KD			THUMBTURN	1	No	
041	026	MOTHER'S SPACE	D1-91-QL	Wood	LH	0.91 m	2.13 m	1.02 m	2.18 m	1.07 m	2.21 m	HM	KD	1/4		PUSH/PULL WITH KEYED DEADBOLT	2	Yes	

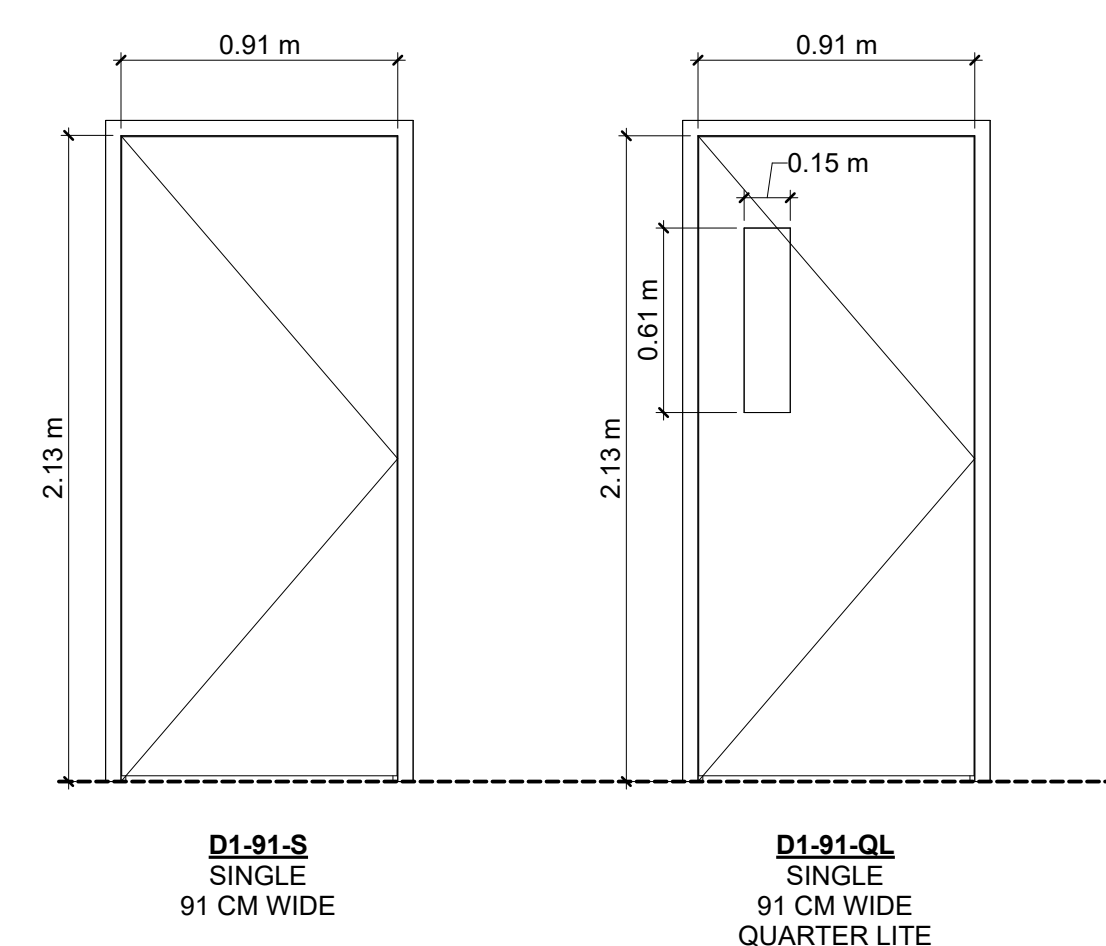

**HINGES**

LABEL	HINGE ID	DESCRIPTION
1	FBB179 4 1/2 X 4 1/2	BALL BEARING, FULL MORTISE, STANDARD WEIGHT HINGES
2	FBB199 4 1/2 X 4 1/2 NRP (32)	BALL BEARING, FULL MORTISE, HEAVY WEIGHT HINGES, STAINLESS STEEL, NON-REMOVEABLE PINS
3	BB855 5 X 6	CONCEALED BEARING, FULL SURFACE, DOUBLE WEIGHT PRISON HINGES

**Door Legend - Phase 2**

SCALE 1 : 25

**Hinge Legend**

SCALE 1 : 5

NO.	DATE	DESCRIPTION
-----	------	-------------

KEY PLAN

**HOPE HEALTH ACTION**

OWNER

**MOTHER'S ROOM RENOVATION**

HCBH HOSPITAL, QUARTIER MORIN, HAITI

PROJECT

**DOOR SCHEDULE - PHASE 2**

DRAWING TITLE

SCALE As indicated DATE 05/17/23

JOB NUMBER 64-001

DRAWN JJ CHECKED Checker

CONSTRUCTION DOCUMENTS

**A901-2**

DRAWING NUMBER

**GENERAL NOTES**

- COMPLETE LAYOUT DRAWINGS SHALL BE REQUIRED BY PARAGRAPH. SUBMITTALS. CONSTRUCTION WORK SHALL NOT START ON ANY SYSTEM UNTIL THE LAYOUT DRAWINGS HAVE BEEN APPROVED.
- ALL WORK SHALL BE IN ACCORDANCE WITH THE BUILDING AND PLUMBING CODES AS WELL AS LOCAL AUTHORITIES HAVING JURISDICTION.
- THE PLUMBING CONTRACTOR SHALL BE REQUIRED TO OBTAIN AND CARRY THE COST ASSOCIATED WITH THE PERMIT PROCESS AND RELATED, CITY REQUIRED INSPECTIONS.
- REFER TO ARCHITECTURAL DRAWINGS AND ELEVATIONS FOR FINAL LOCATIONS OF ALL NEW PLUMBING FIXTURES ASSOCIATED TRIM.
- REFER TO THE ARCHITECTURAL DRAWINGS FOR THE CEILING HEIGHTS WHICH SHALL BE MAINTAINED.
- THE PIPING SYSTEMS SHOWN ON THE DRAWINGS ARE SHOWN DIAGRAMMATICALLY WITHOUT EVERY OFFSET AND TRANSITION REQUIRED TO INSTALL THE WORK. OBVIOUS OFFSETS AND TRANSITIONS, AS RELATED TO PLUMBING ARE SHOWN WHERE POSSIBLE WITHOUT AFFECTING THE CLARITY OF THE DRAWINGS.
- ALL MATERIALS INSTALLED IN THIS SCOPE OF WORK SHALL BE NEW UNLESS SPECIFICALLY NOTED FOR RE-USE.

**GENERAL**

	EXISTING PIPING TO BE REMOVED
	HEAVY LINE INDICATES NEW WORK
	LIGHT LINE INDICATES EXISTING WORK
	PIPING INTERRUPTED OR TO BE CONTINUED
	CAP OR END OF PIPE
	CONNECT TO EXISTING
	DETAIL #
	DRAWING #
	DIRECTION OF SLOPE
	ELBOW DOWN OR DROP
	ELBOW UP OR RISE
	FLOW IN DIRECTION OF ARROW
	HANDICAPPED ACCESSIBLE
	TEE LOOKING DOWN
	TEE LOOKING UP

**WATER**

	CW	COLD WATER
	HW	HOT WATER
	HWR	HOT WATER RETURN
	NP-	NON POTABLE COLD WATER
	NPH-	NON POTABLE HOT WATER
	TP	TRAP PRIMER

**ABBREVIATIONS**

AFF	ABOVE FINISH FLOOR
AFG	ABOVE FINISH GRADE
AP	ACCESS PANEL
AC	ABOVE CEILING
AD	ACCESS DOOR
ARCH	ARCHITECT
BT	BATH TUB FIXTURE IDENTIFICATION
BPW	BED PAN WASHER FIXTURE IDENTIFICATION
BLDG	BUILDING
CI	CAST IRON
CFM	CUBIC FEET PER MINUTE
CLNG	CEILING
CLDI	CEMENT LINED DUCTILE IRON
CP	CHROME PLATED
DIA	DIAMETER
DWG	DRAWING
EL	ELEVATION
FFE	FINISH FLOOR ELEVATION
FLR	FLOOR
FT	FOOT
FRS	FLUSHING RIM SERVICE SINK
GALV	GALVANIZED
GC	GENERAL CONTRACTOR
GPM	GALLONS PER MINUTE
HB	HOSE BIBB
HVAC	HEAT, VENTILATION & AIR CONDITIONING
ID	INSIDE DIAMETER
INV	INVERT
L	LAVATORY FIXTURE IDENTIFICATION
MAX	MAXIMUM
MIN	MINIMUM
MSB	MOP SERVICE BASIN FIXTURE IDENTIFICATION
N/A	NOT APPLICABLE
NC	NORMALLY CLOSED
NO	NORMALLY OPEN
NTS	NOT TO SCALE
NIC	NOT IN CONTRACT
OD	OUTSIDE DIAMETER
PC	PLUMBING CONTRACTOR
POS	PROVIDED UNDER OTHER SECTION
SS	SERVICE SINK FIXTURE IDENTIFICATION
SH	SHOWER FIXTURE IDENTIFICATION
SK	SINK FIXTURE IDENTIFICATION
SPEC	SPECIFICATION
ST. ST.	STAINLESS STEEL
SF	SQUARE FEET
TYP	TYPICAL
UR	URINAL FIXTURE IDENTIFICATION
WC	WATER CLOSET FIXTURE IDENTIFICATION

**NEW WORK NOTES**

- ALL PIPING TO BE INSTALLED STRAIGHT AND TRUE IN RELATION TO EACH OTHER. PROPER CLEARANCES AND ACCESS TO BALL VALVES TO BE MAINTAINED.
- A MINIMUM OF 1/8" PER FOOT SHALL BE MAINTAINED ON ALL WASTE PIPING 4" AND LARGER, AND 1/4" PER FOOT FOR 3" AND SMALLER.
- PLUMBING PIPING AND EQUIPMENT SHALL NOT BE SUPPORTED FROM OTHER TRADES. PLUMBING PIPING CAN BE RACKED TOGETHER BUT SHOULD BE INDEPENDENT FROM OTHER TRADES.
- PLUMBING CONTRACTOR SHALL SEAL PIPING PENETRATIONS THROUGH FIRE AND SMOKE RATED PARTITIONS WITH APPROVED FIRE STOP MATERIAL.
- ALL WORK IN THIS SECTION SHALL BE COORDINATED WITH ALL OTHER TRADES PRIOR TO BEGINNING INSTALLATION.
- ALL COMPONENTS THAT COULD COME IN CONTACT WITH POTABLE DRINKING WATER, INCLUDING BUT NOT LIMITED TO: FAUCETS, VALVES, FITTINGS, ETC., SHALL BE LEAD-FREE, AS REQUIRED UNDER NSF 61.
- ALL NEW PIPING SHALL RUN ABOVE CEILINGS AND BEHIND FINISHED SURFACES UNLESS OTHERWISE NOTED.
- THE PLUMBING CONTRACTOR SHALL OBTAIN INSTALLATION INSTRUCTION ON EACH PIECE OF EQUIPMENT TO BE FURNISHED WHICH THE CONTRACTOR IS REQUIRED TO INSTALL OR TO WHICH FINAL CONNECTIONS ARE TO BE MADE UNDER THE PLUMBING CONTRACT. THE PLUMBING CONTRACTOR SHALL INSTALL AND MAKE FINAL CONNECTIONS PER THE MANUFACTURER'S INSTRUCTION AND RECOMMENDATIONS. THE CONTRACTOR SHALL DEMONSTRATE TO THE OWNER THAT THE INSTALLED EQUIPMENT OPERATES AS DESIGNED.
- COORDINATE ALL MOTORS, STARTERS, AND DISCONNECTS WITH ELECTRICAL CONTRACTOR PRIOR TO PURCHASE AND INSTALLATION.
- ALL PLUMBING PIPING AND EQUIPMENT SHALL BE INSTALLED, COORDINATED WITH ALL TRADES, IN SUCH A WAY SO THAT LIGHTS, CONDUITS, SPRINKLERS, SUPPLY AND/OR DRAIN PIPING AND HVAC EQUIPMENT AND ACCESS PANELS ARE NOT OBSTRUCTED.
- ALL FIXTURES TO BE INSTALLED WITH BALL VALVES ON THE WATER SUPPLY FOR ISOLATION OF FIXTURE OR FIXTURE GROUP DEPENDING ON APPROACH SHOWN ON DRAWINGS.

**DRAINAGE**

	SAN	SANITARY DRAIN
	SAN	SANITARY BURIED
	V	SANITARY VENT
	V	SANITARY VENT BURIED
	W	SOIL / SANITARY WASTE
	W	SOIL / SANITARY WASTE BURIED
	AD	AREA DRAIN
	CO	CLEANOUT
	FCO	FLOOR CLEANOUT
	FD	FLOOR DRAIN
	GCO	GROUND CLEANOUT
	OD	OVERFLOW DRAIN / SECONDARY ROOF DRAIN
	P-TRAP	P-TRAP
	WCO	WALL CLEANOUT

**VALVES & ACCESSORIES**

	BALANCING VALVE
	BALL VALVE
	CHECK VALVE
	GATE VALVE
	GATE VALVE NORMALLY CLOSED
	PRV PRESSURE REDUCING / REGULATING VALVE
	RPBP REDUCED PRESSURE BACKFLOW PREVENTER (2" OR LESS)
	VIV VALVE IN VERTICAL
	FM FLOW METER
	GH GROUND HYDRANT
	HB HOSE BIBB
	IN-LINE FILTER
	PIPE GUIDE / BEAM PENETRATION
	PG PRESSURE GAUGE
	STRAINER
	TG TEMPERATURE GAUGE
	TP TRAP PRIMER
	UNION
	VB VACUUM BREAKER
	WH WALL HYDRANT
	WHA WATER HAMMER ARRESTOR / SHOCK ABSORBER

HHA PLUMBING FIXTURE SCHEDULE				CONNECTIONS			
Tag #	FIXTURE TYPE	MANUFACTURER	MODEL	CW	HW	SAN	VENT
P-1	WATER CLOSET	AMERICAN STANDARD, CADET PRO, ELONGATED, 12" ROUGH	#3527C.101.020 WHT. PRO TANK 1.28 GPF #356354	1/2"	NA	4"	2"
	SEAT	CENTOCO ELONGATED PLATIC WHITE OPEN SEAT,	#500CC-001				
	WAX RING/JONI BOLTS	FLUIDMASTER REINFORCED EXTRA-THICK	#7514				
P-2	WALL HUNG LAVATORY	AMERICAN STANDARD LUCERNE WALL HUNG	LUCERNE 0356.421(1 HOLE)	1/2"	NA	1.5"	1.5"
	FAUCET	T & S BRASS SINGLE PANTRY FAUCET, DECK MOUNT	#B-0305				
	DRAIN	ZURN	816-PCH				
P-3	SHOWER W/2" FLOOR DRAIN	CUSTOM BUILT SHOWER BY OTHERS	N/A	1/2"	NA	1.5"	1.5"
	FLOOR DRAIN	AB & A ADJUSTIBLE ,ROUND GRATE, CHROME BRASS W/ CLAMP RING	#67027				
	SHOWER VALVE & EXPOSED PIPE	JALCO EXPOSED PIPE 90D SHOWER RAIL 7 DIVERTER	#EXP-90SD				
	WALL SPIGOT	T & S BRASS SILL FAUCET SELF CLOSING	#B-0706				
	SHOWER HEAD	AMERICAN STANDARD FLOWISE	#1660.711 Shower Head				
P-4	MOP SINK W/ 2" Floor Drain	CUSTOM BUILT TILE BASIN BY OTHERS		1/2"	NA	2"	1.5"
	FLOOR DRAIN-	AB & A ADJUSTIBLE , ROUND GRATE, CHROME BRASS W/ CLAMP RING	#67027				
	SPIGOT-	T & S BRASS, HOSE BIBB W/ WRIST LEVER, W/ VACUMN BREAKER	#b-0702-WH4				
P-5	STAINLESS STEEL WALL HUNG HAND SINK	ADVANCED TABCO SS WALL MOUNT SINK	#7-PS-71	1/2"	NA	1.5"	1.5"
	DRAINS (3) LEVER	DRAIN T&S B-3952 TWIST WASTE VALVE	#B-3952				
P-20	AREA FLOOR DRAIN	AB & A, HD CHROMED BRASS	#4850 B2	NA	NA	3"	1.5"
P-21	FLOOR SINK	ZURN CAST IRON FLOOR SINK, 1/2" GRATE 12" X 12", 6" DEEP	#FD2375-NH3-H	NA	NA	3"	1.5"
P-22	FLOOR CLEAN OUT	ZURN 4" SPIGOT X FIP, PVC C.O. W/ THREADED PLUG	#G71640	NA	NA	4"	NA
P-23	END CLEAN OUT	4" DWV PVC Cleanout Adapter and Plug	#(D112-040 / P105X-040)	NA	NA	4"	NA

KEY PLAN

**HOPE HEALTH ACTION**

OWNER

**HHA NICU**  
ENTER ADDRESS HERE

PROJECT

**PLUMBING GENERAL NOTES & SYMBOLS**

DRAWING TITLE

SCALE 12" = 1'-0" DATE MM/DD/YYYY

JOB NUMBER 64-001

DRAWN Author CHECKED Checker

Current Package

**P001**

DRAWING NUMBER

5/22/2023 2:53:48 PM

NO.	DATE	DESCRIPTION

KEY PLAN

**HOPE HEALTH ACTION**

OWNER

**HHA NICU**  
ENTER ADDRESS HERE

PROJECT

**PLUMBING SANITARY WATER LEVEL 1**

DRAWING TITLE

SCALE 1/4" = 1'-0" DATE MM/DD/YYYY


JOB NUMBER 64-001

DRAWN Author CHECKED Checker


Current Package

**P101**

DRAWING NUMBER

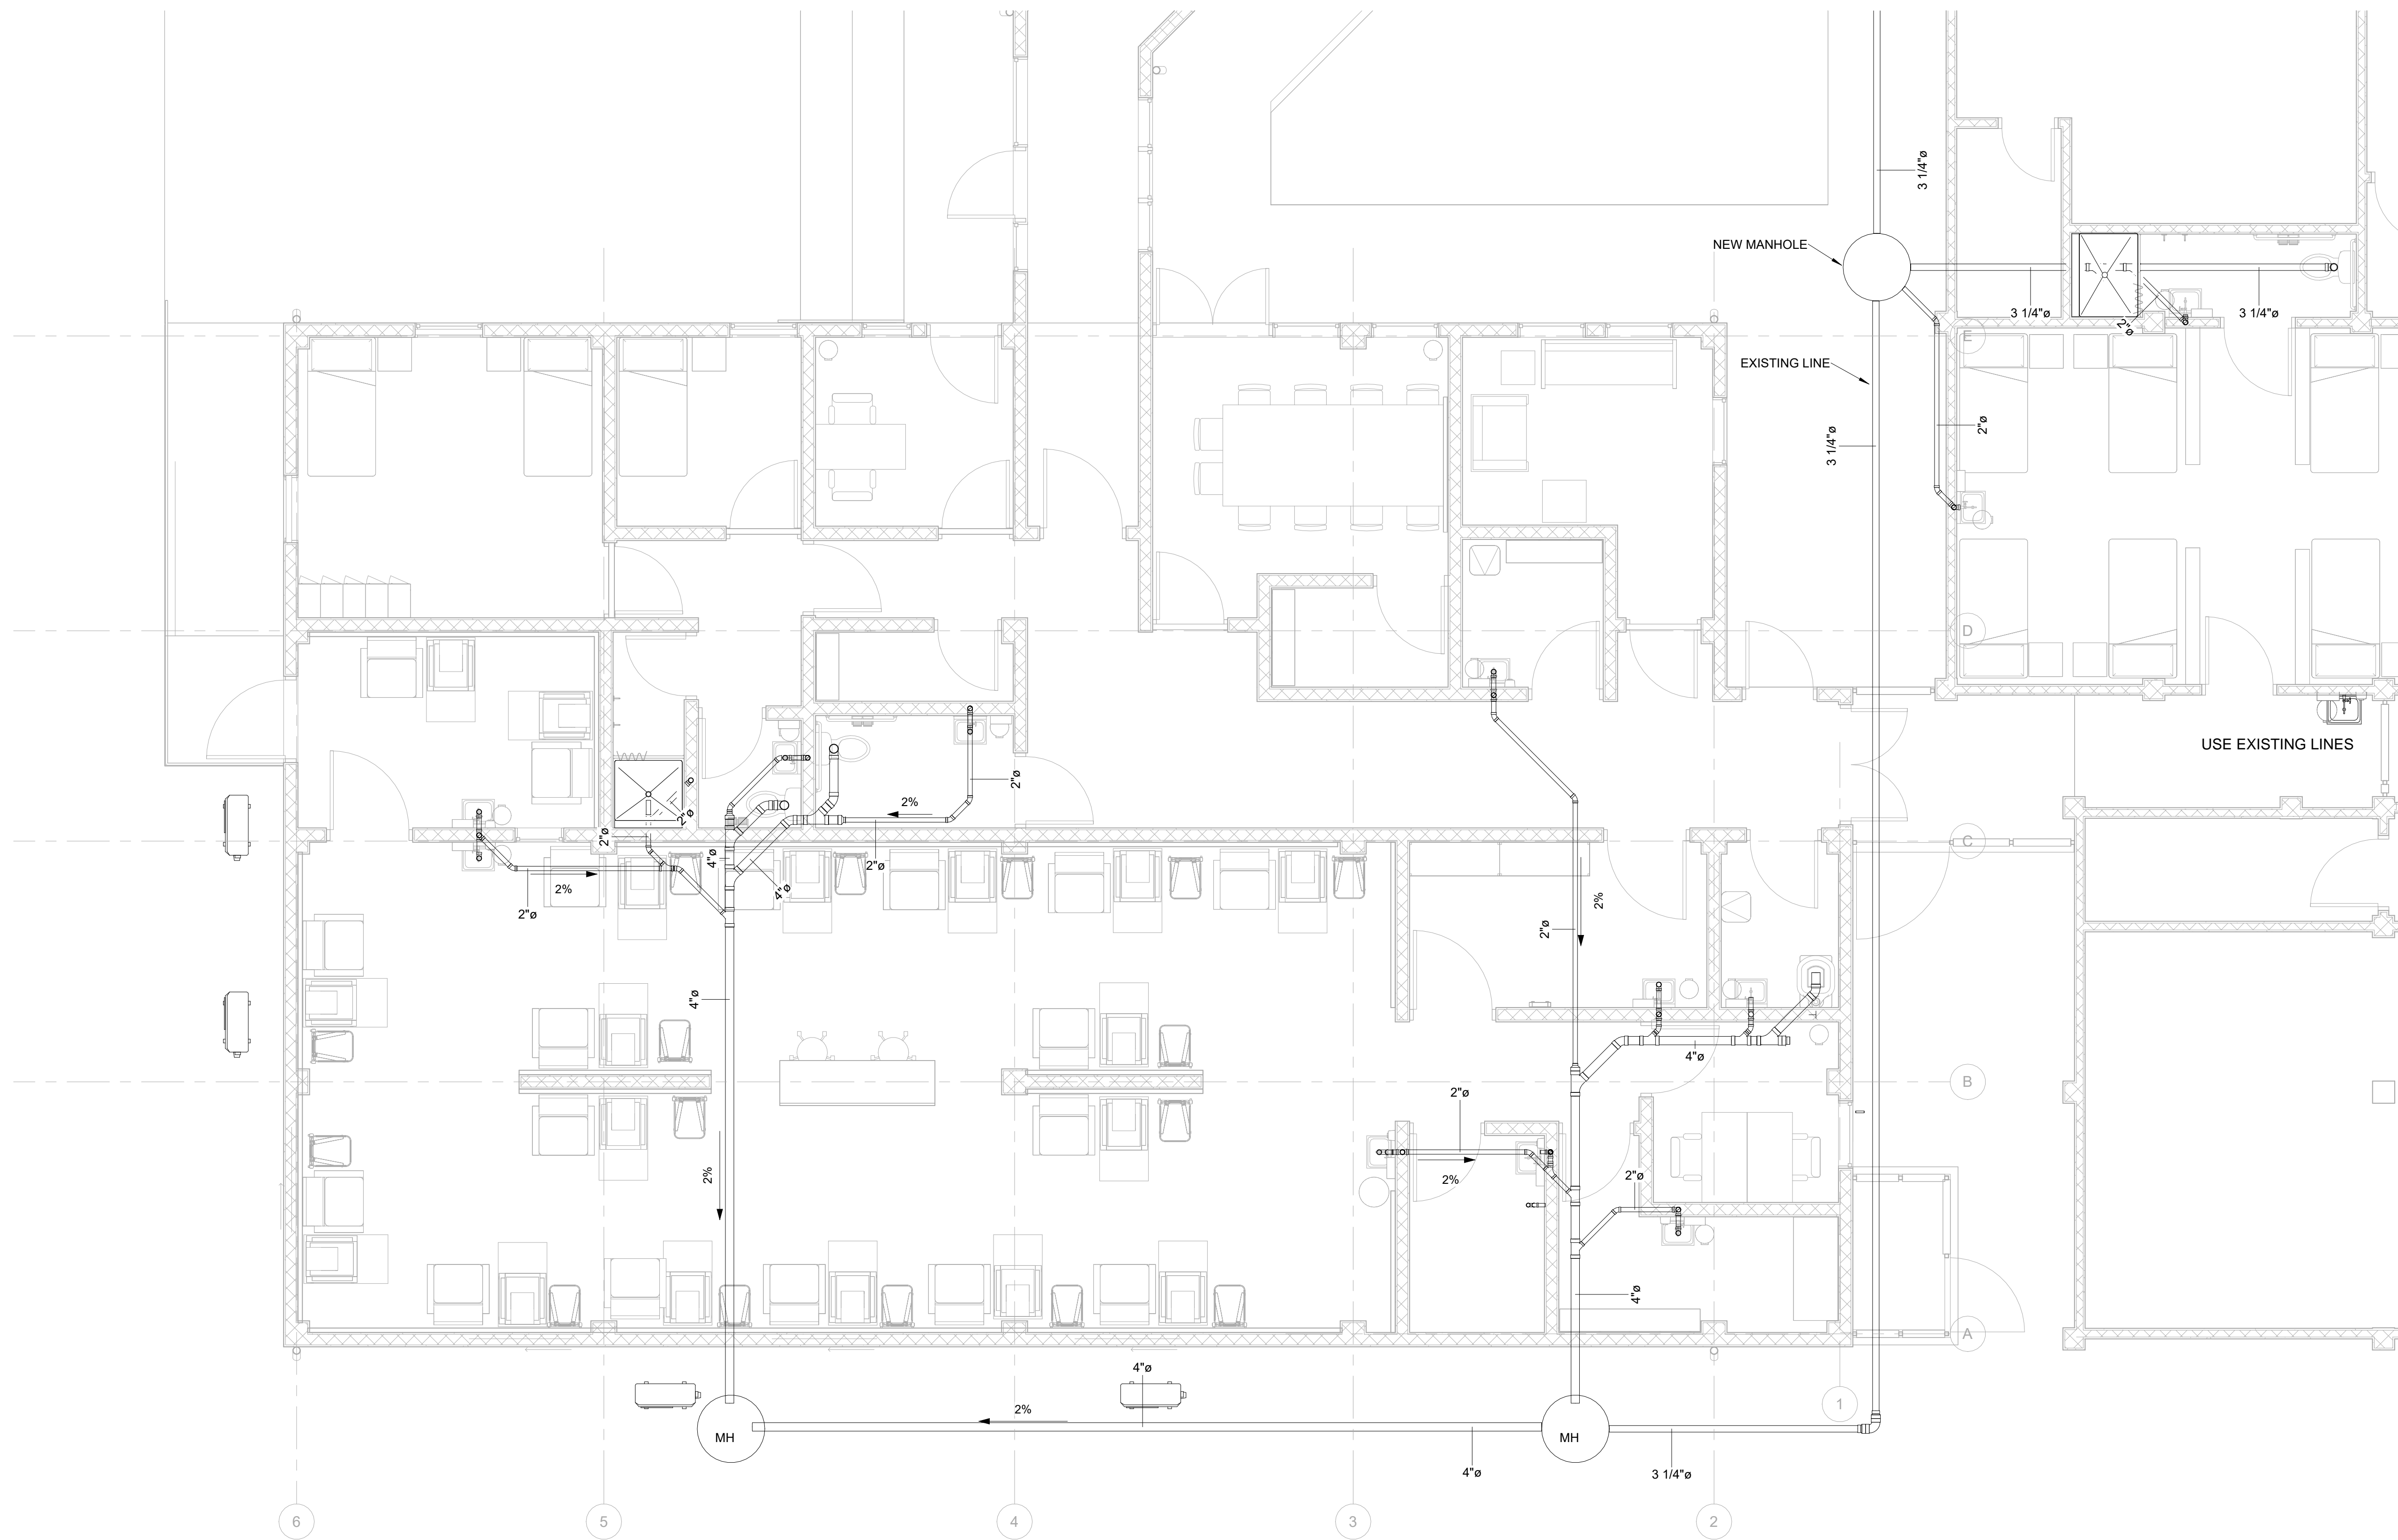

**1 Plumbing Plan - SANITARY LEVEL 1**  
SCALE 1/4" = 1'-0"

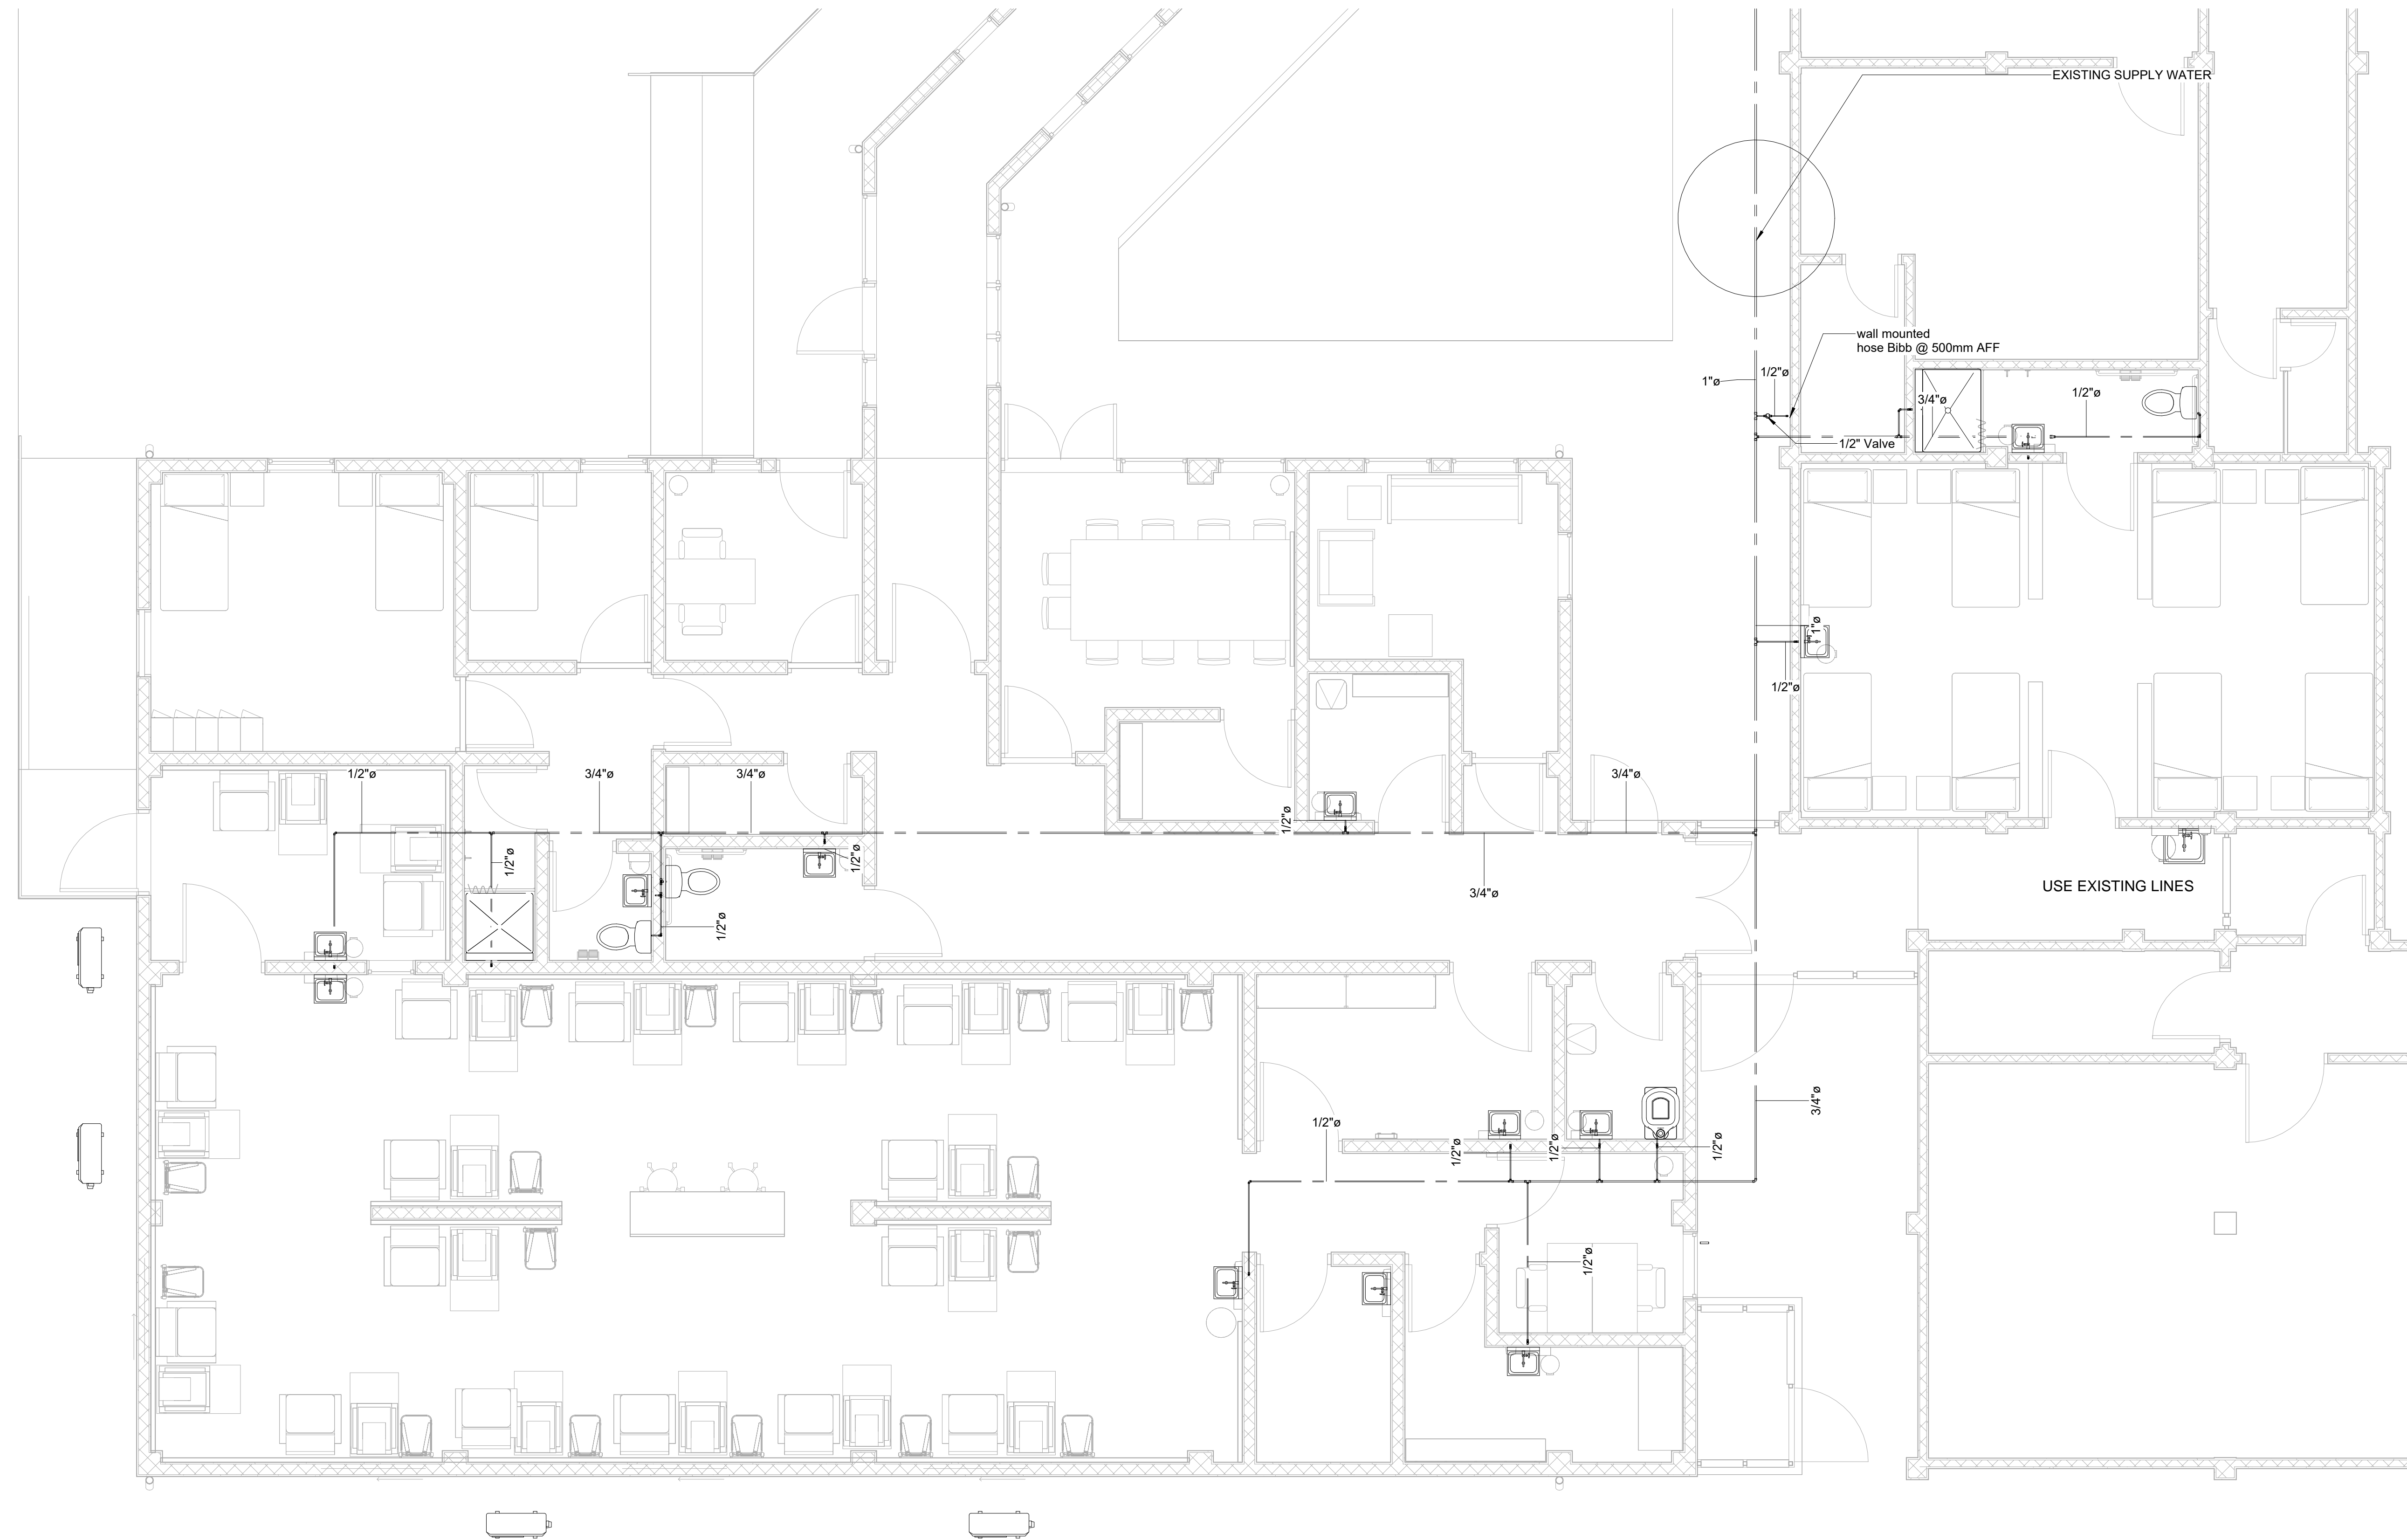

Plumbing Plan - DOMESTIC COLD WATER

**1** LEVEL 1  
SCALE 1/4" = 1'-0"

5/22/2023 2:53:51 PM

NO.	DATE	DESCRIPTION

KEY PLAN

**HOPE HEALTH ACTION**

OWNER

**HHA NICU**  
ENTER ADDRESS HERE

PROJECT

**PLUMBING DOMESTIC COLD WATER LEVEL 1**

DRAWING TITLE

SCALE 1/4" = 1'-0"	DATE 01/06/23
--------------------	---------------

JOB NUMBER 64-001

DRAWN Author	CHECKED Checker
--------------	-----------------

Current Package

**P103**

DRAWING NUMBER